
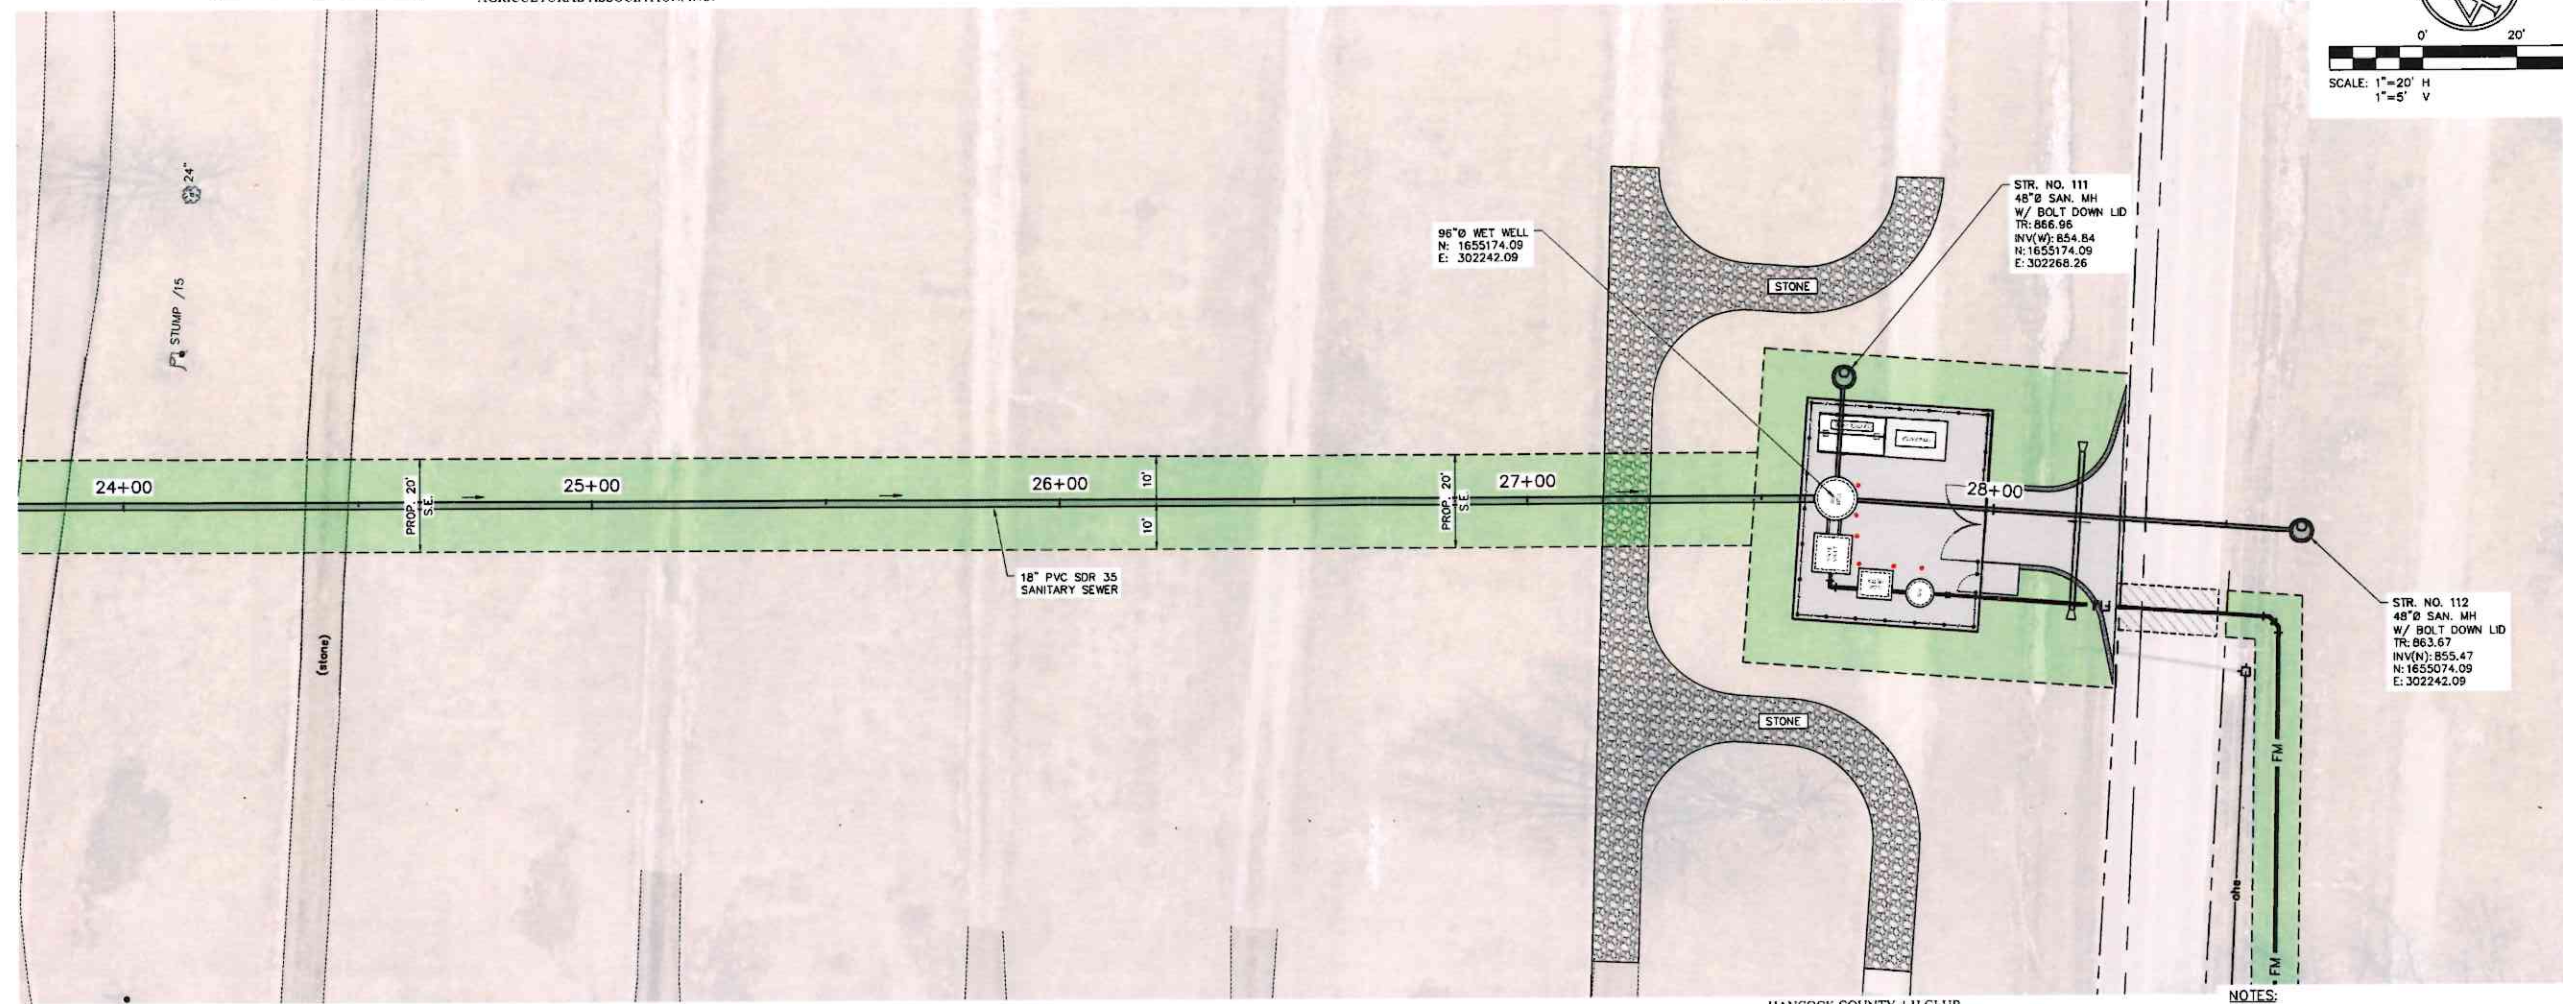


100 YEAR FLOOD  
PLAIN EL. 869.0

HANCOCK COUNTY 4-H CLUB  
AGRICULTURAL ASSOCIATION, INC.

HANCOCK COUNTY 4-H CLUB  
AGRICULTURAL ASSOCIATION, INC.

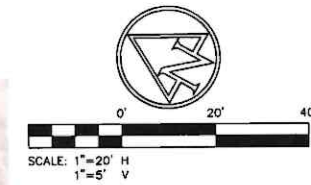

HANCOCK COUNTY 4-H CLUB  
AGRICULTURAL ASSOCIATION, INC.

HANCOCK COUNTY 4-H CLUB  
AGRICULTURAL ASSOCIATION, INC.

NOTES:

1. SEE DEMOLITION PLANS ON SHEET C-107 FOR REMOVAL AND ABANDONMENT INFORMATION.
2. SEE SHEET C-116 FOR SITE PLAN.

PLOT DATE: 1/16/2024 8:45 AM. EDITED BY: PTRAWINSKI. DRAWING FILE: \\INDYSAMP\PROJECTS\2021\02592\0. DRAWINGS\UTILITY\_INFRASTRUCTURE\2021\02592\LUI\_PP.DWG

CITY OF  
GREENFIELD



9025 River Road | Suite 200 | Indianapolis, Indiana 46240  
TEL 317.547.5580 | FAX 317.543.0270  
www.structurepoint.com

**WATERVIEW  
LIFT STATION  
RELOCATION**

Greenfield, Indiana



*Bryan L. Hood* 1/12/2024  
CERTIFIED BY


ISSUANCE INDEX	
DATE:	1/12/2024
PROJECT PHASE:	CONSTRUCTION DOCUMENTS

REVISION SCHEDULE		
NO.	DESCRIPTION	DATE

Project Number 2021.02592

**PLAN AND PROFILE  
SANITARY SEWER**

**C-112**

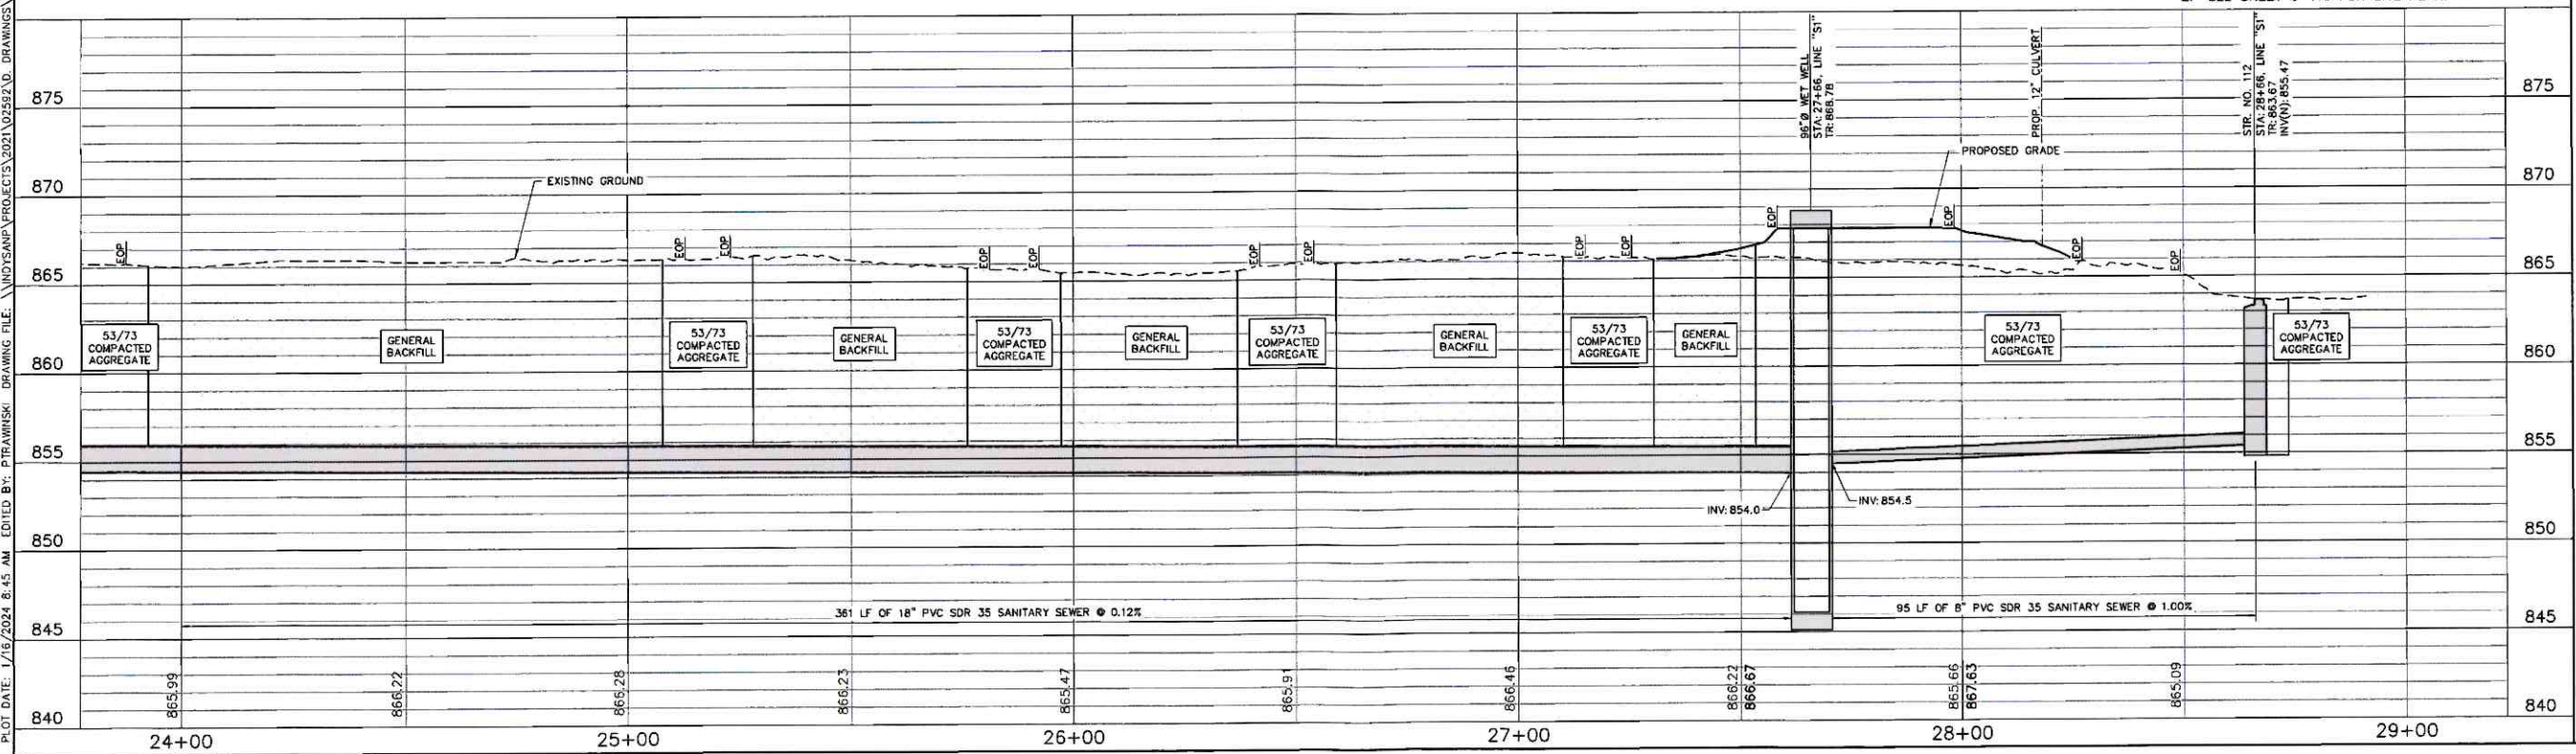

875  
870  
865  
860  
855  
850  
845  
840

24+00 25+00 26+00 27+00 28+00 29+00



AMERICAN STRUCTUREPOINT INC.  
 9025 River Road | Suite 200 | Indianapolis, Indiana 46240  
 TEL 317.547.5590 | FAX 317.543.0270  
 www.structurepoint.com

WATERVIEW LIFT STATION RELOCATION

Greenfield, Indiana



Bryan L. Hood 1/12/2024  
 CERTIFIED BY

ISSUANCE INDEX	
DATE:	1/12/2024
PROJECT PHASE:	CONSTRUCTION DOCUMENTS

REVISION SCHEDULE		
NO.	DESCRIPTION	DATE

Project Number 2021.02592


PLAN AND PROFILE FORCE MAIN

C-115

100 YEAR FLOOD PLAIN EL. 869.0




SCALE: 1"=20' H  
 1"=5' V

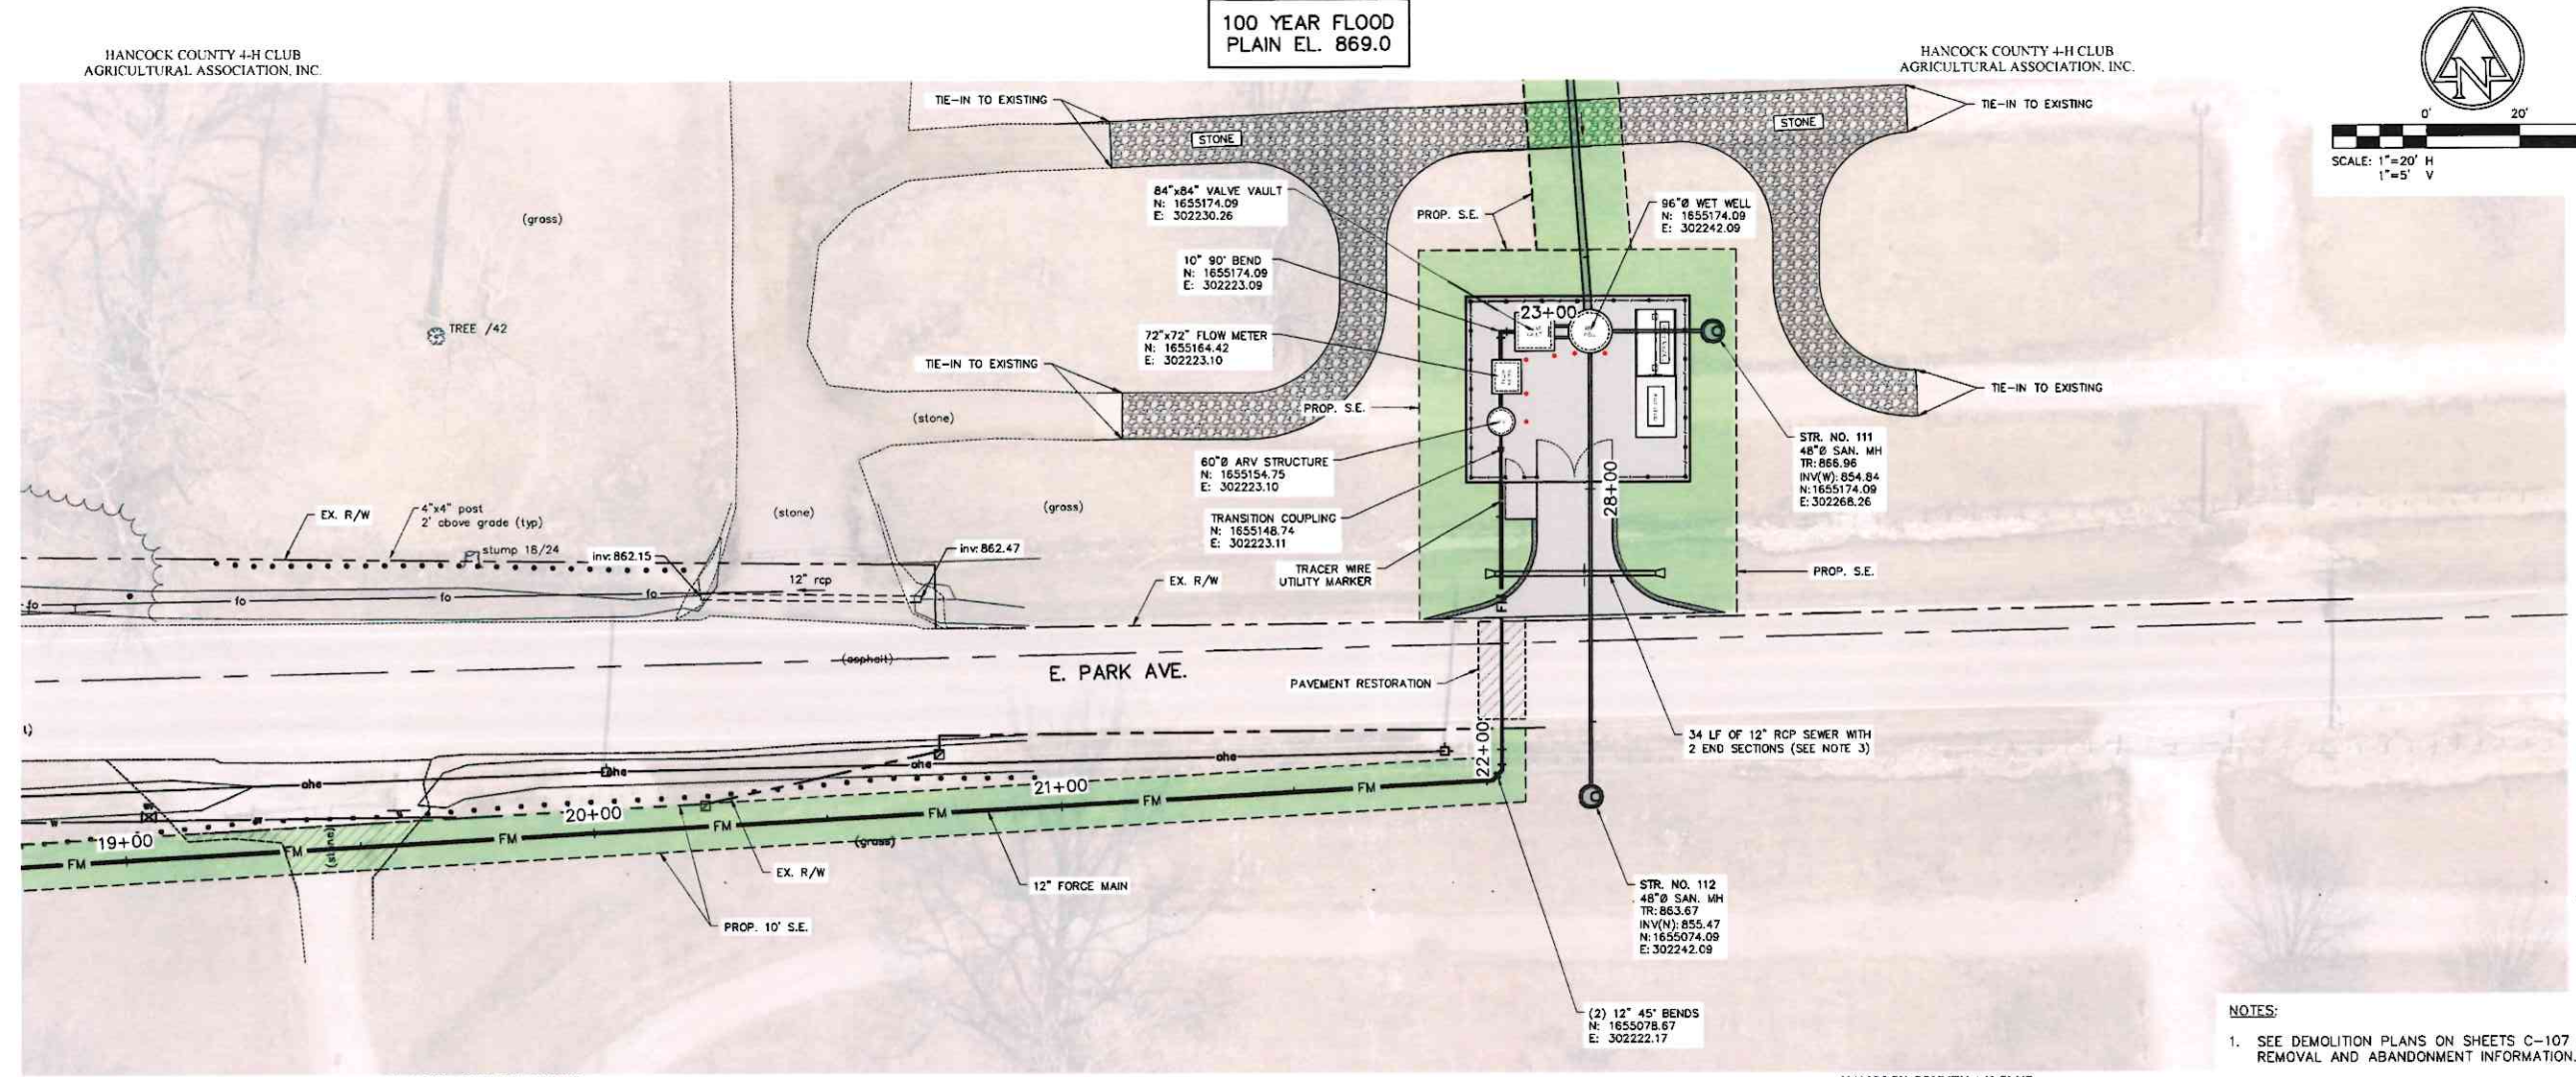

- NOTES:
- SEE DEMOLITION PLANS ON SHEETS C-107 FOR REMOVAL AND ABANDONMENT INFORMATION.
  - INSTALL FORCE MAIN TO MAINTAIN POSITIVE SLOPE TO AIR RELEASE VALVE.
  - PARTIAL RE-GRADING REQUIRED AT END SECTIONS TO MAINTAIN FLOW TO WEST.



PLOT DATE: 1/16/2024 8:45 AM EDITED BY: PITRANWSKI DRAWING FILE: \\INDY\SANP\PROJECTS\2021\02592\0. DRAWINGS\UTILITY\_INFRASTRUCTURE\202102592\UI.PPP.DWG

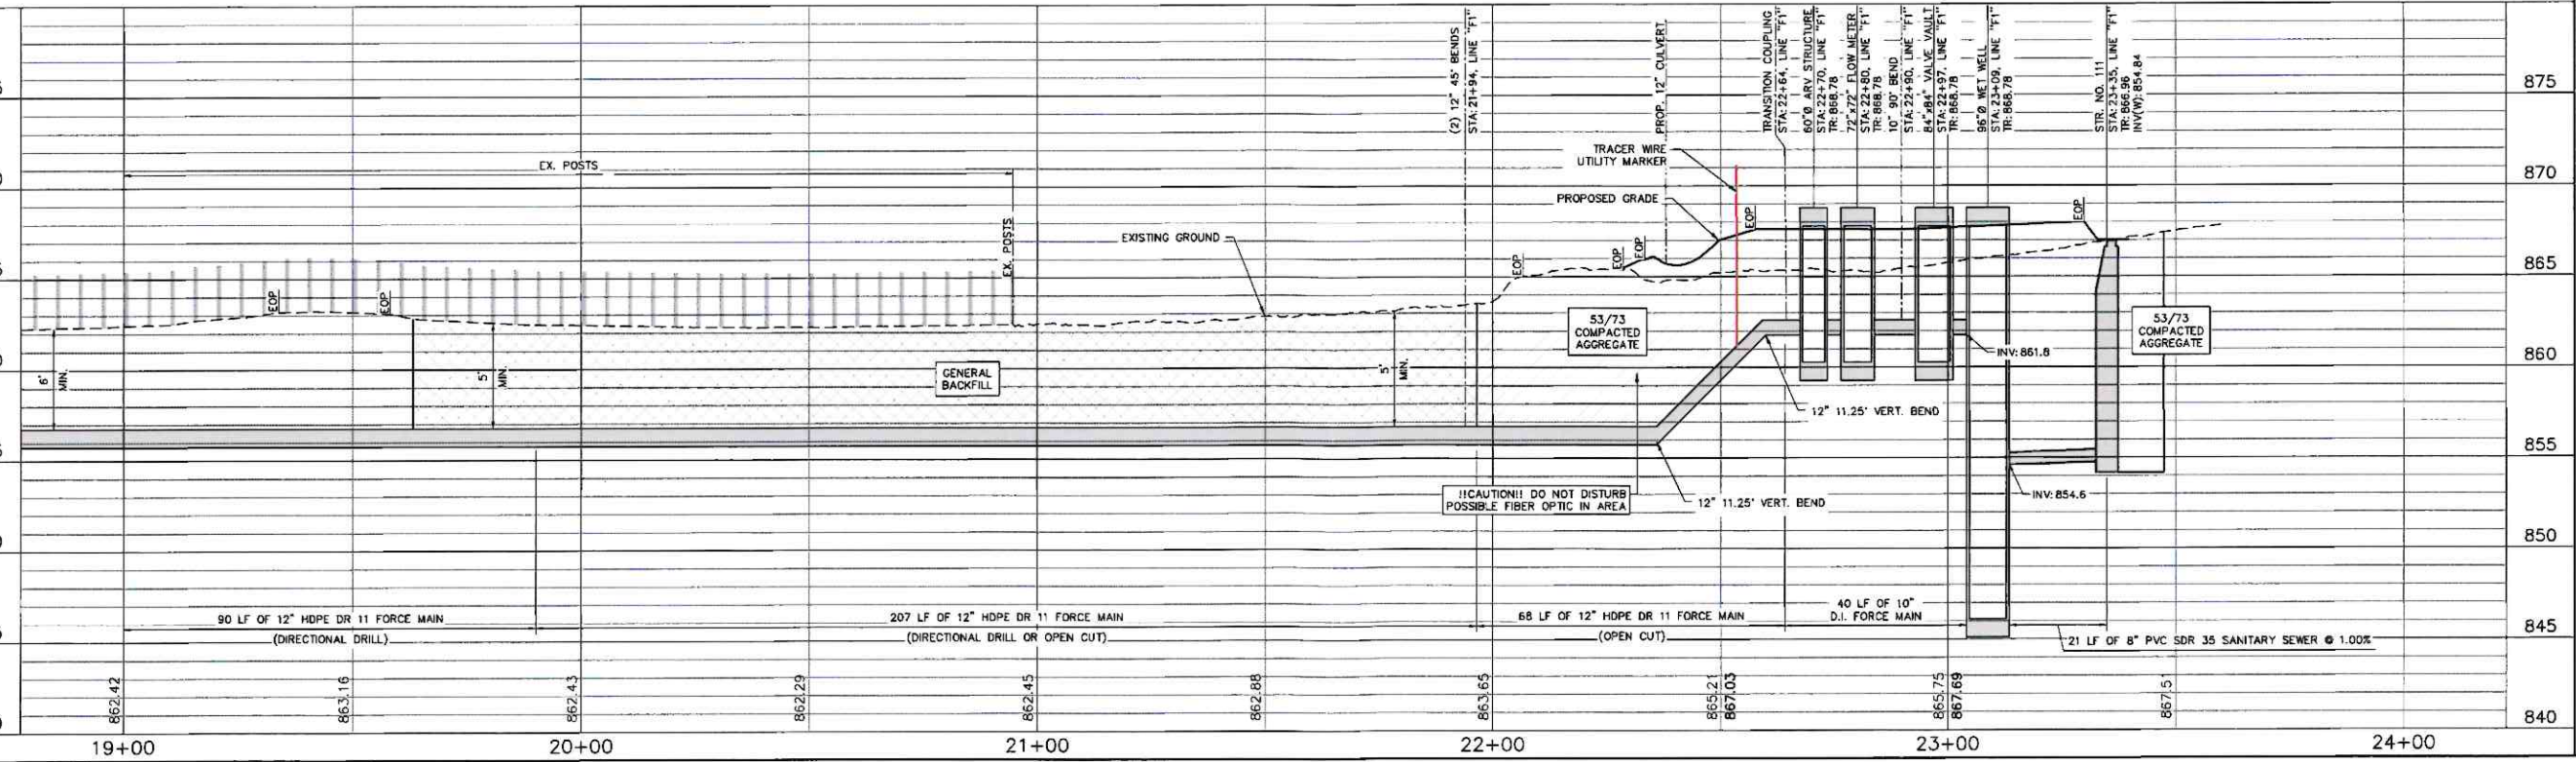

875  
870  
865  
860  
855  
850  
845  
840

19+00 20+00 21+00 22+00 23+00 24+00

PLOT DATE: 1/16/2024 8:45 AM EDITED BY: PIRAMUSKI DRAWING FILE: \\INDYSANV\PROJECTS\2021\02592\0. DRAWINGS\UTILITY\_INFRASTRUCTURE\202102592.U1.SP.DWG

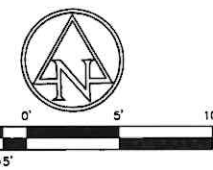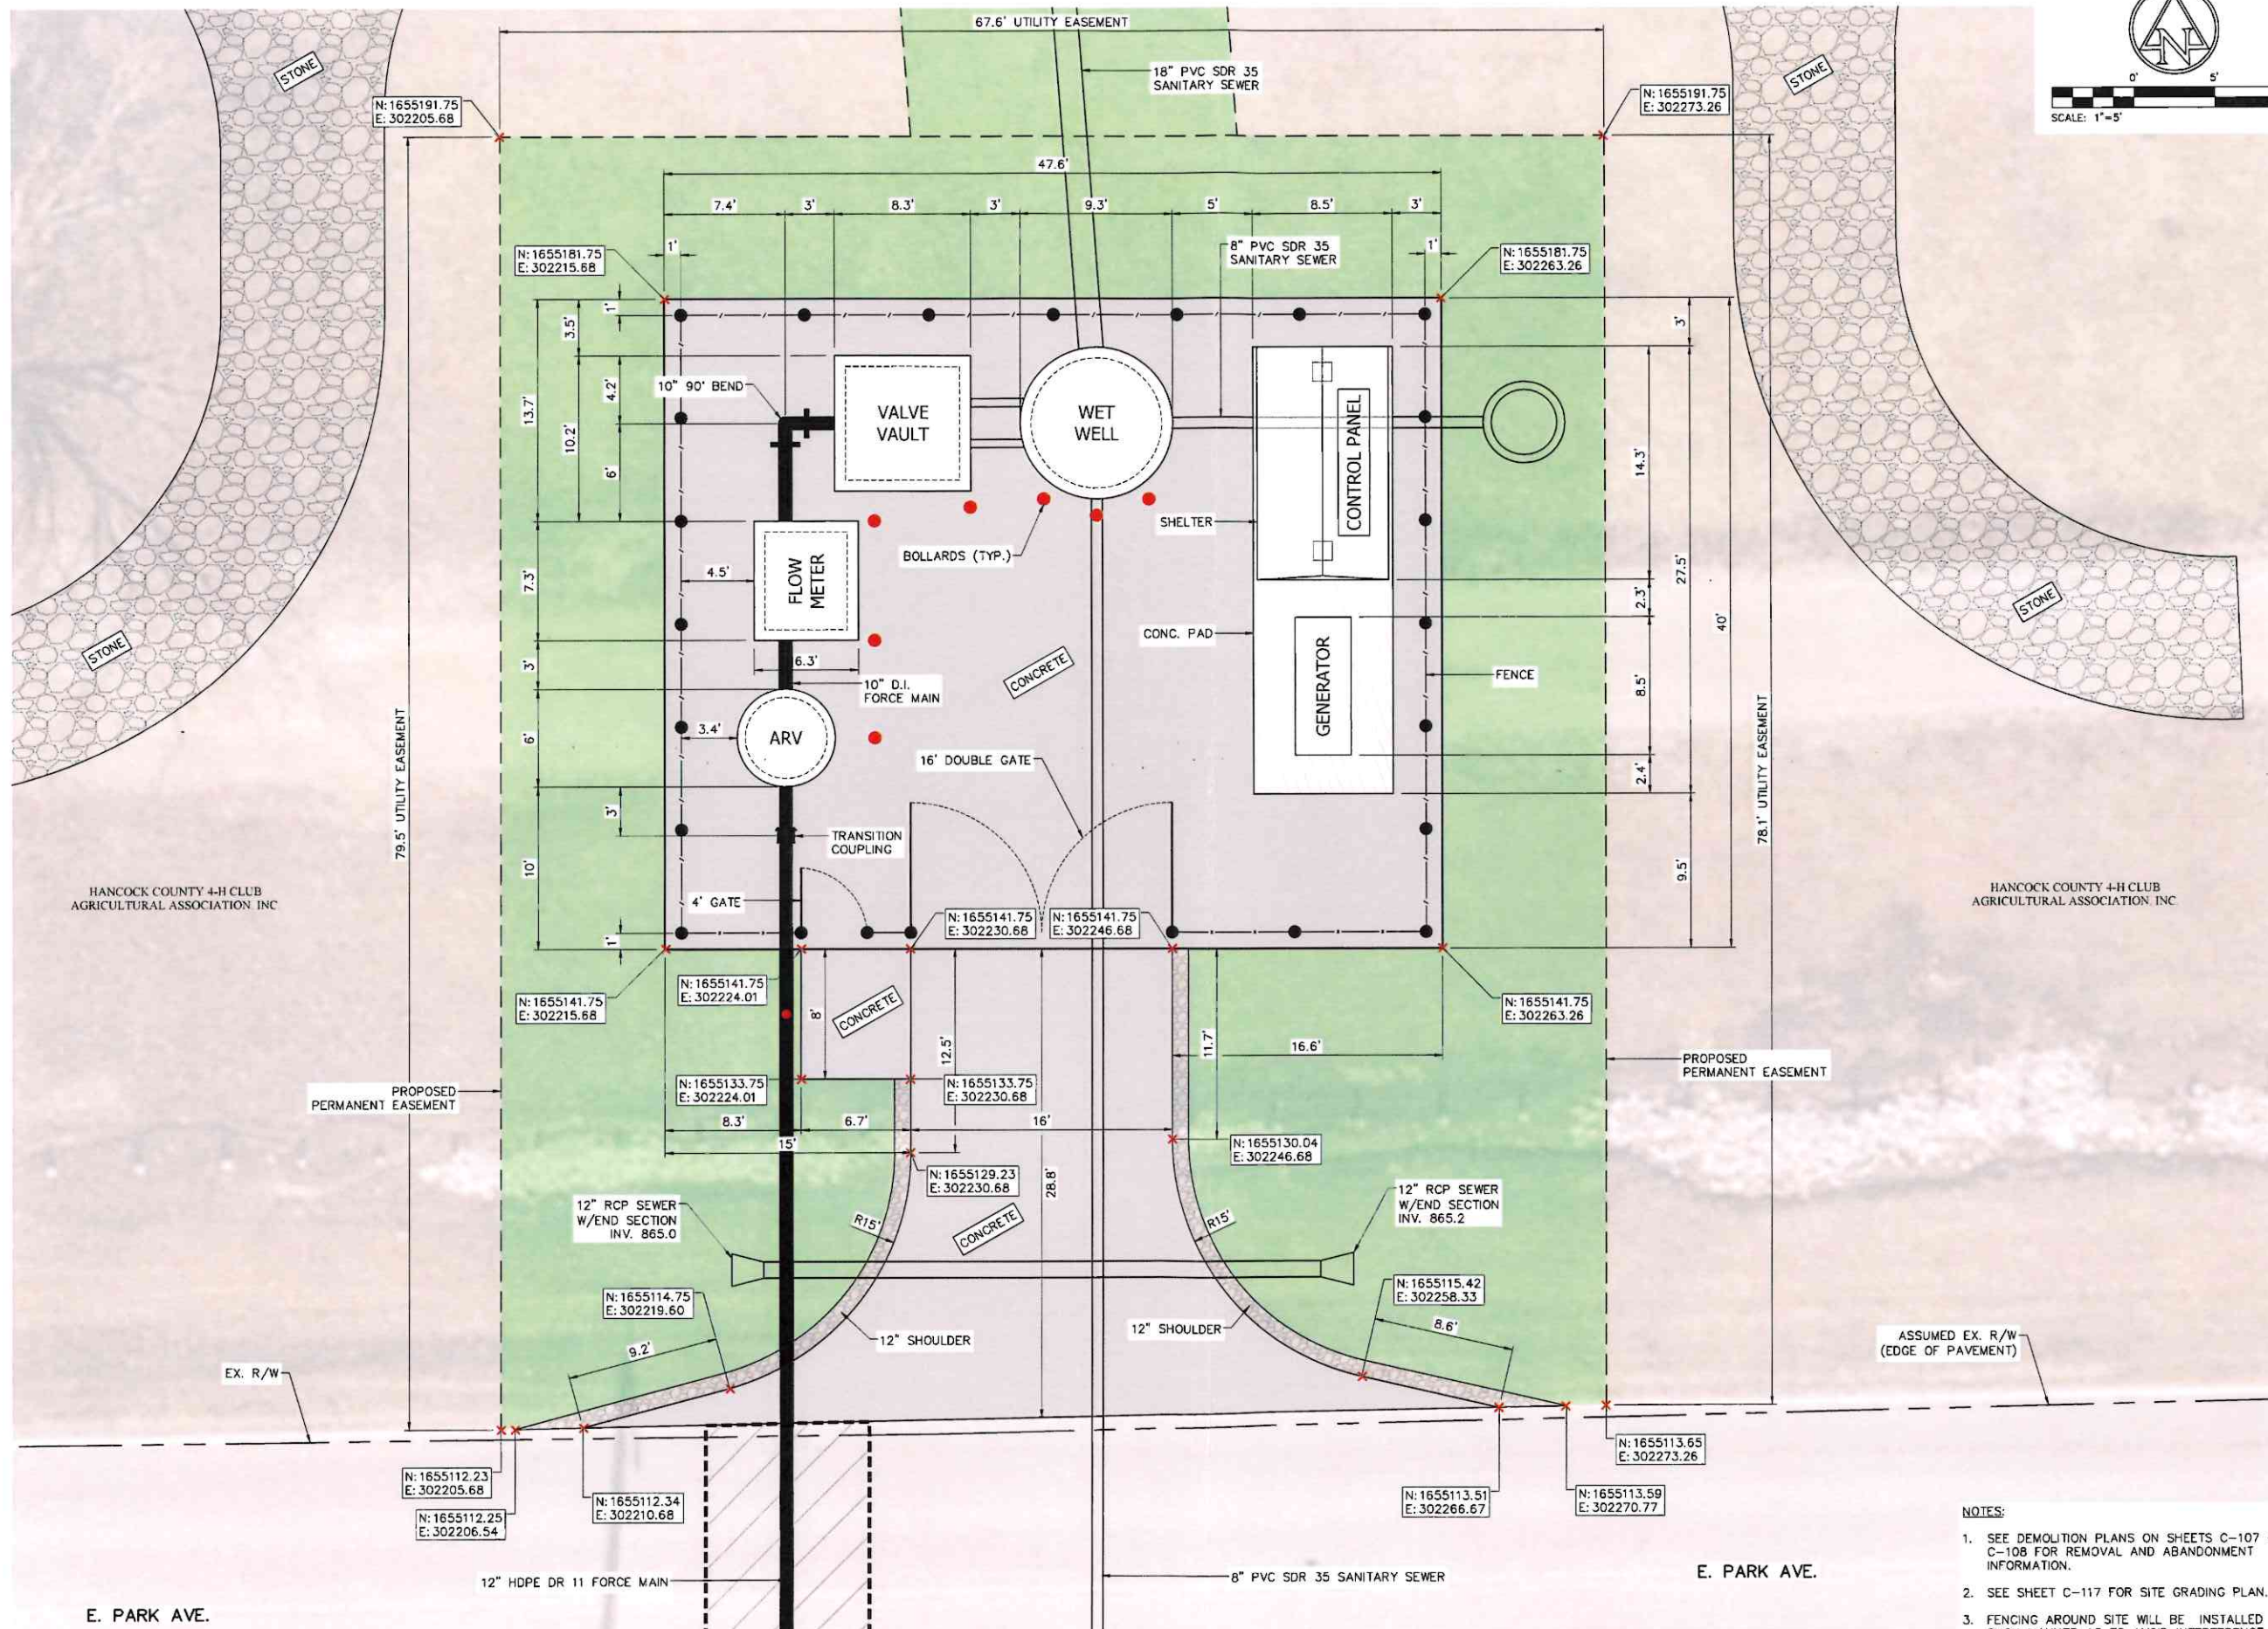

**AMERICAN STRUCTUREPOINT INC.**  
 9025 River Road | Suite 200 | Indianapolis, Indiana 46240  
 TEL 317.547.5580 | FAX 317.543.0270  
 www.structurepoint.com

**WATERVIEW LIFT STATION RELOCATION**

Greenfield, Indiana



*Bryan L. Hood* 1/12/2024  
 CERTIFIED BY

ISSUANCE INDEX	
DATE:	1/12/2024
PROJECT PHASE:	CONSTRUCTION DOCUMENTS

REVISION SCHEDULE		
NO.	DESCRIPTION	DATE

Project Number 2021.02592

- NOTES:**
- SEE DEMOLITION PLANS ON SHEETS C-107 - C-108 FOR REMOVAL AND ABANDONMENT INFORMATION.
  - SEE SHEET C-117 FOR SITE GRADING PLAN.
  - FENCING AROUND SITE WILL BE INSTALLED IN SUCH MANNER AS TO AVOID INTERFERENCE WITH UTILITIES.

**SITE PLAN PROPOSED**  
**C-116**